

**LEGEND**

- - - STORMWATER DRAINAGE PIPE
- - - SUBSOIL DRAIN
- SIDE ENTRY PIT
- MANHOLE
- ▲ HEADWALL
- DRIVEWAY LOCATION
- 17.0 DESIGN SURFACE CONTOURS (0.2m INTERVAL)
- 17.0 EXISTING SURFACE CONTOURS (0.2m INTERVAL)
- - - EXISTING STORMWATER DRAINAGE
- - - E-HV EXISTING HIGH VOLTAGE ELECTRICAL
- - - E-LV EXISTING LOW VOLTAGE ELECTRICAL
- - - S EXISTING SEWERAGE
- - - W EXISTING WATER RETICULATION
- SSD PROPOSED SUBSURFACE DRAIN TO BE CONNECTED TO EXISTING SUBSURFACE DRAIN

AS CONSTRUCTED INFORMATION  
 CERTIFIED BY BRIERTY PTY LTD

SCALE 1:500 (A1)  
 1:1000 (A3) 0 10 20 30 40 50m

**AS CONSTRUCTED**

REV	DATE	DRAWN	REVD	APPD	REVISION
1	28.04.15	JAH	RJB	LM	AS CONSTRUCTED
0	20.02.15	JAH	RJB	LM	ISSUED FOR CONSTRUCTION




CLIENT TERRITORY LIFE		DRAWING CHECK RJB		REVIEWED L.MUIR	APPROVED D.CAMERON
PROJECT MITCHELL CREEK GREEN STAGE 2B		DESIGNED RJB	DESIGN REVIEW LM	DATE 5/12/2014	DATE 5/12/2014

TITLE DRAINAGE PLAN SHEET 1 OF 2		
SCALE AS SHOWN	DRAWING No DB05941.200-ECC-DG-0021	REV 1

DATE: 8/05/2015 10:21:39 AM LOGIN NAME: LOCATION: C:\Users\Jah\My Documents\Projects\mitchell\_creek\_green\project\dwg\project\stage2b\mitchell\_creek\_green\_stage2b\_dg-0021.dwg



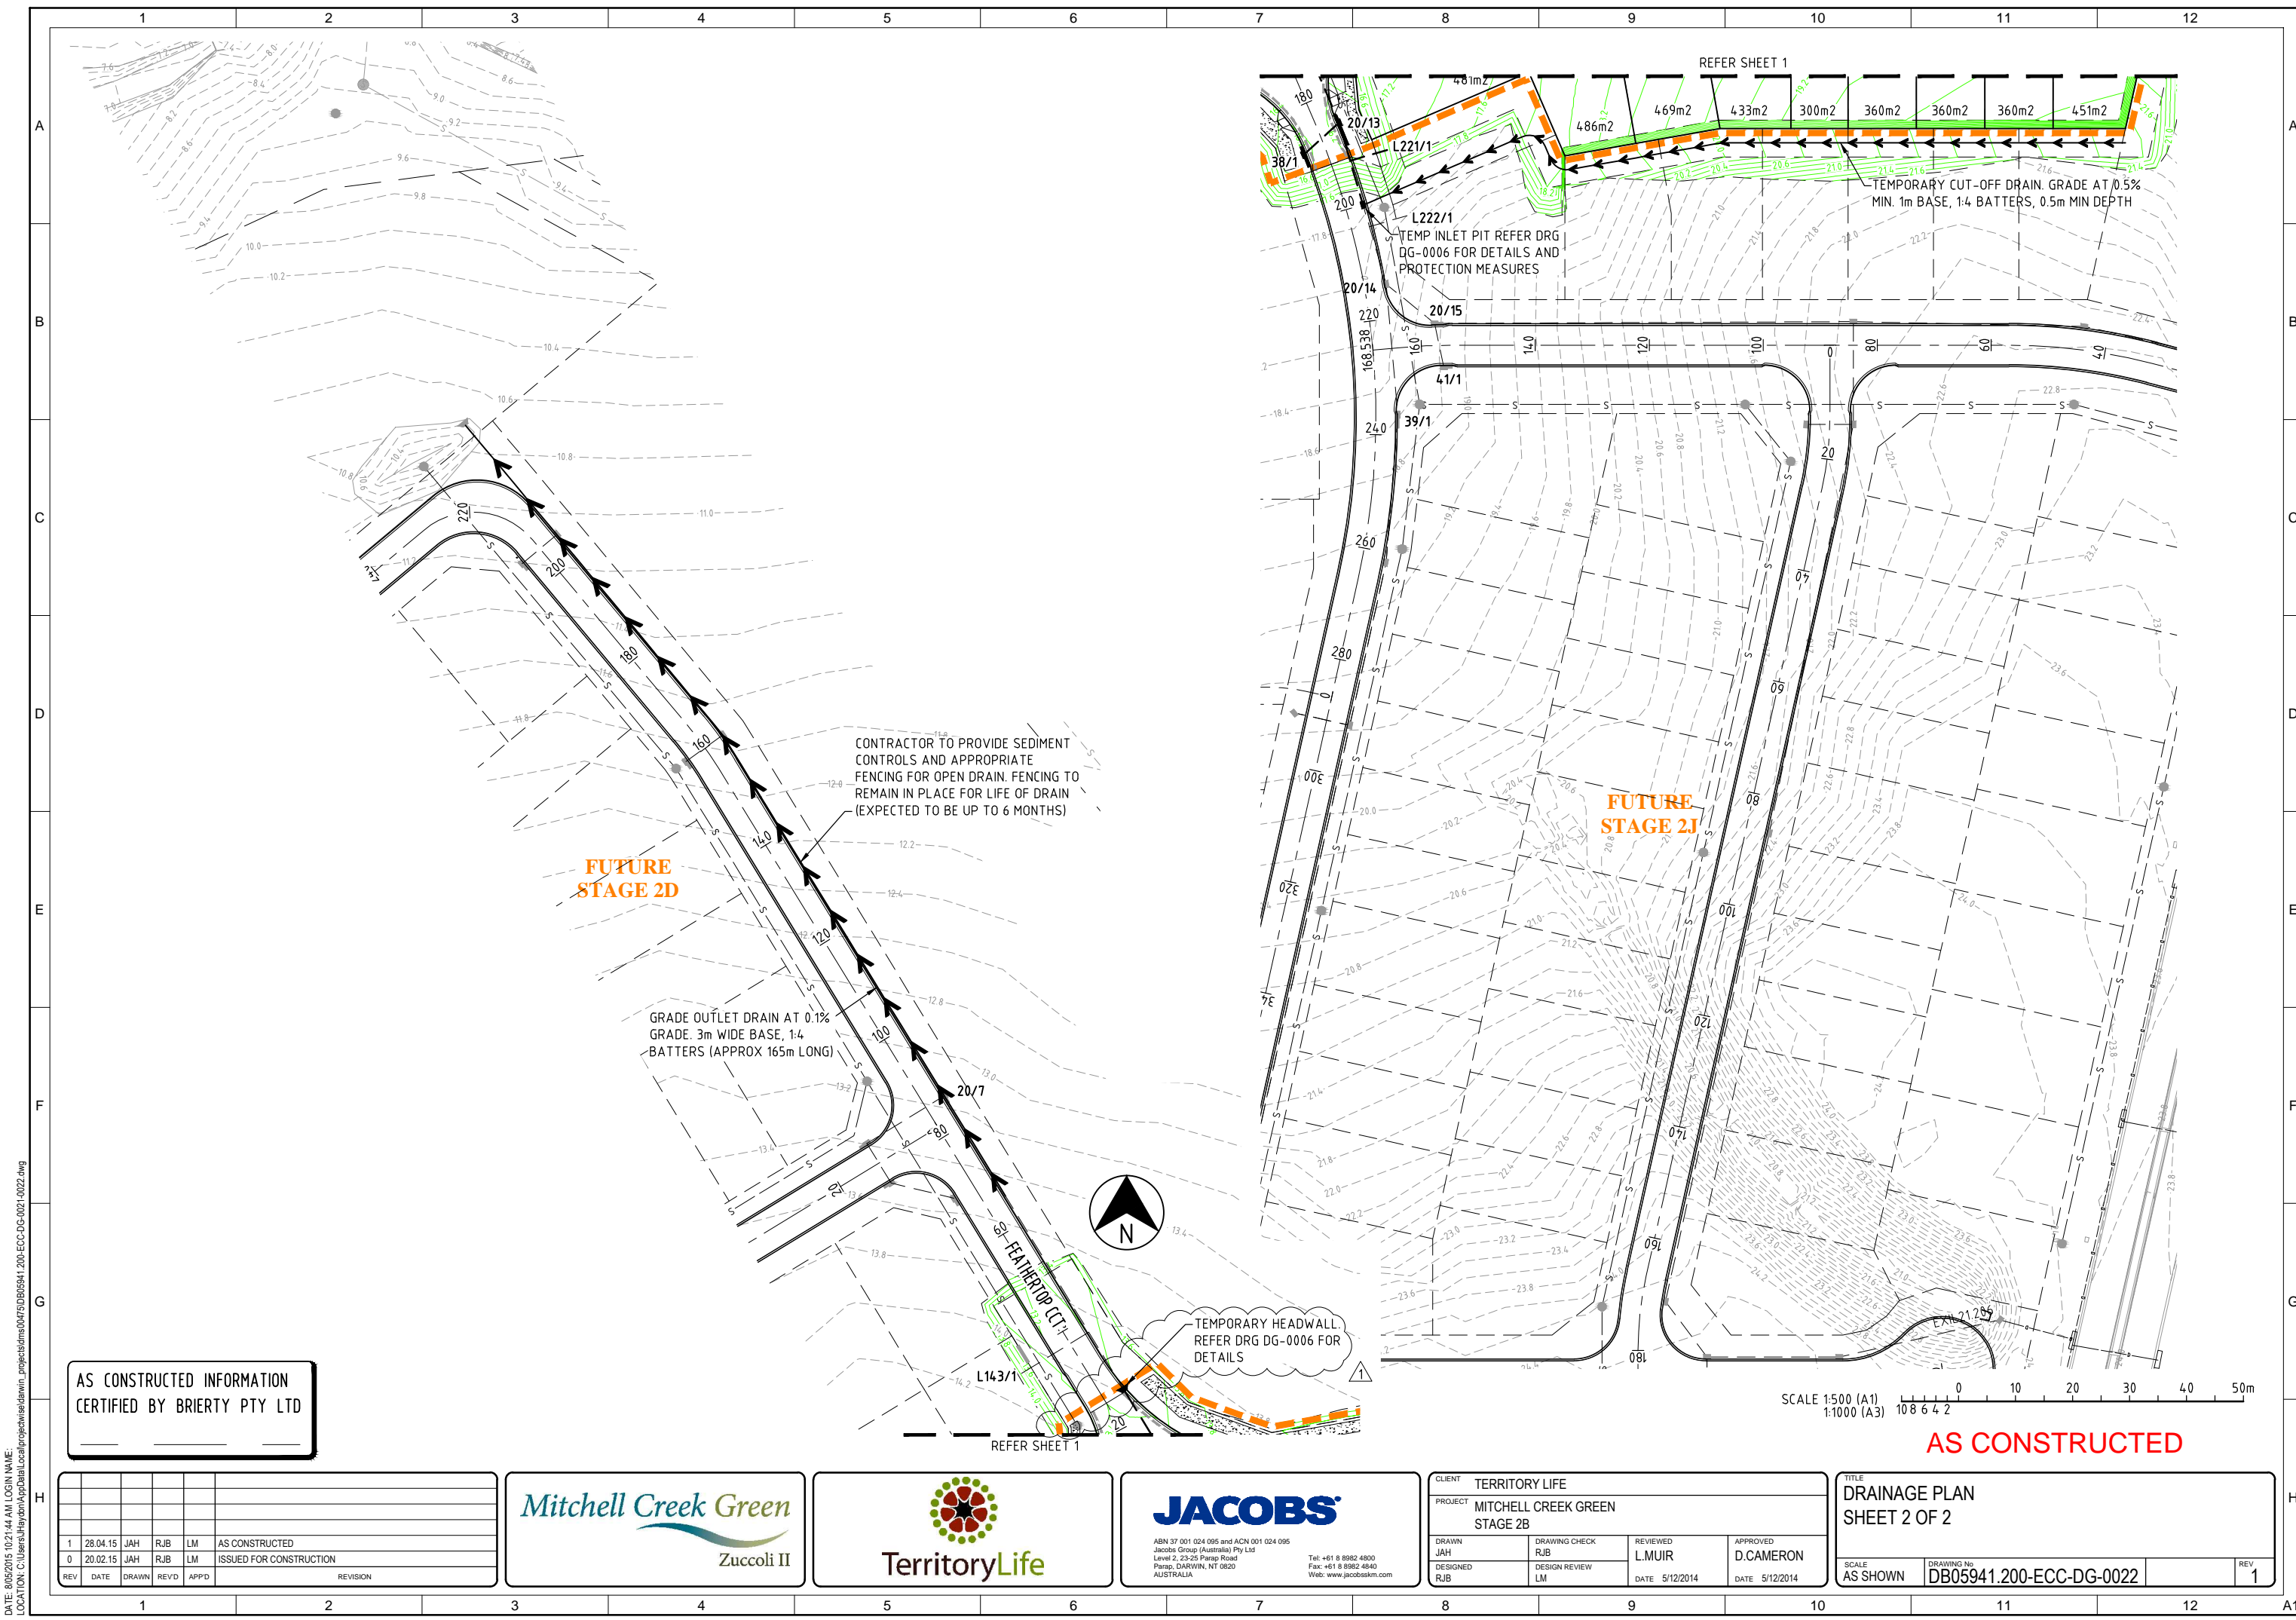

AS CONSTRUCTED INFORMATION  
 CERTIFIED BY BRIERTY PTY LTD

REV	DATE	DRAWN	REVD	APPD	REVISION
1	28.04.15	JAH	RJB	LM	AS CONSTRUCTED
0	20.02.15	JAH	RJB	LM	ISSUED FOR CONSTRUCTION



CLIENT TERRITORY LIFE		REVIEWED L.MUIR	
PROJECT MITCHELL CREEK GREEN STAGE 2B		APPROVED D.CAMERON	
DRAWN JAH	DESIGNED RJB	DATE 5/12/2014	DATE 5/12/2014

TITLE DRAINAGE PLAN SHEET 2 OF 2		
SCALE AS SHOWN	DRAWING No DB05941.200-ECC-DG-0022	REV 1

DATE: 8/05/2015 10:21:44 AM LOGIN NAME: LOCATION: C:\Users\jhaydn\AppData\Local\projectwise\darwin\_projects\dms01\FSD\B05941.200-ECC-DG-0021-0022.dwg